

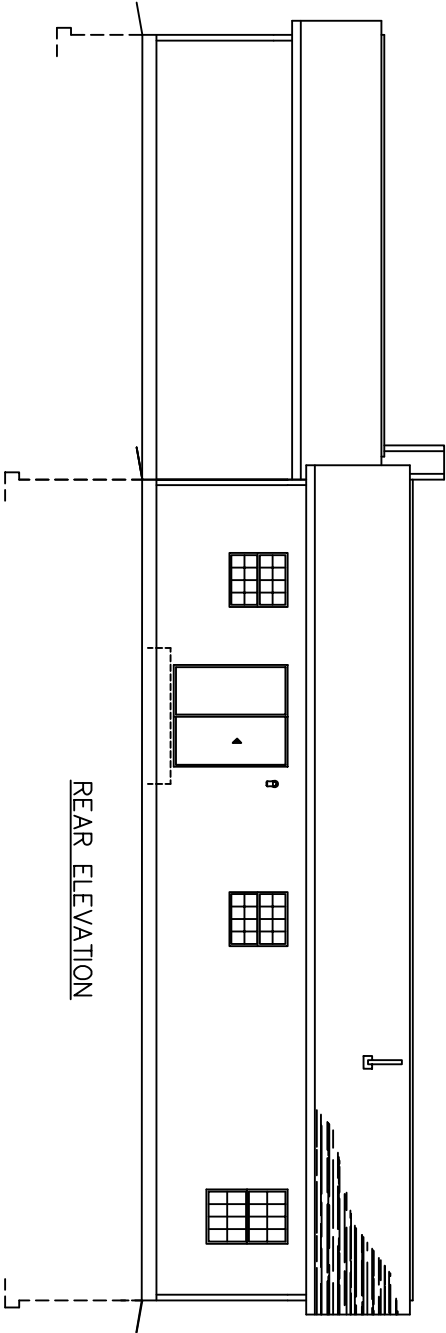
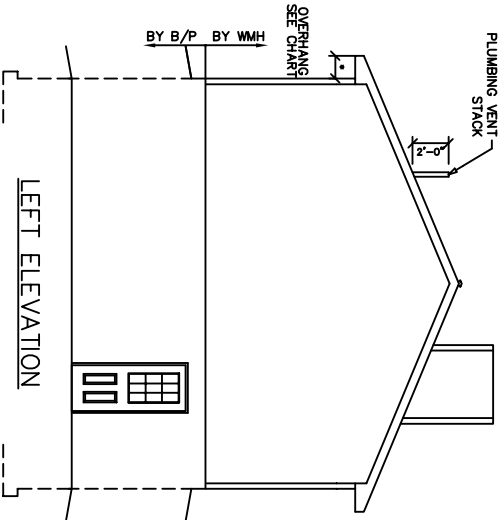
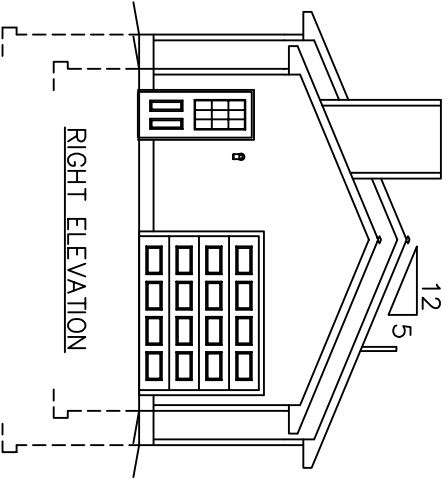


OVERHANG DIMENSION (*)				
ROOF PITCH		HOUSE WIDTH		
		24'-0"	26'-0"/30'-0"/27'-8"/31'-8"	
5/12	16"	11"	16"	16"
7/12	16"	11"	16"	16"
9/12	12"	11"	12"	12"
12/12	8 3/4"	8 3/4"	8 3/4"	8 3/4"

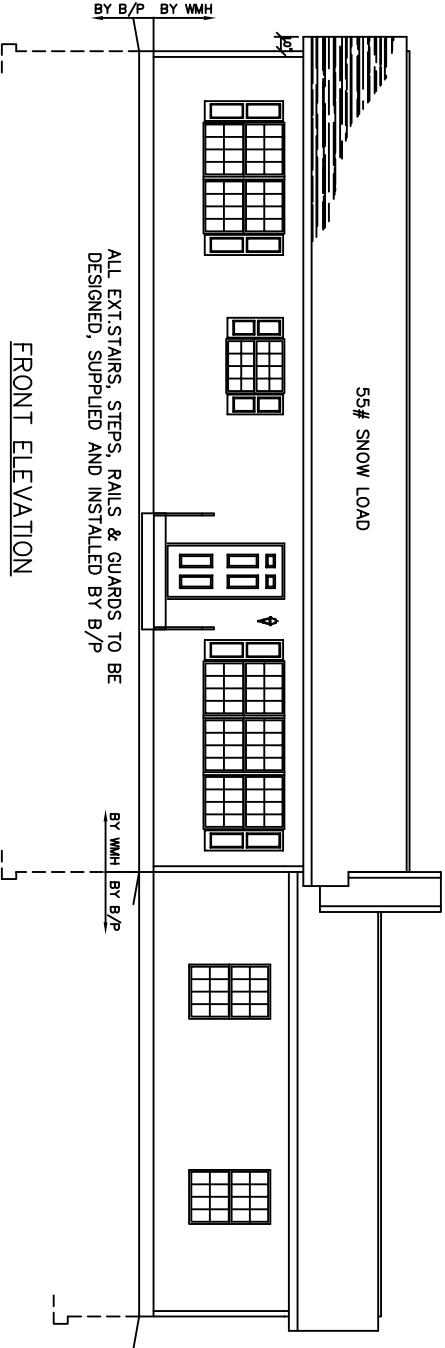

SEE STANDARD NOTES & DETAILS DWG #8

USE GROUP: SINGLE FAMILY CONST. TYPE: 5B DESIGNER: L.TRACEY DATE: 05-23-03 SCALE: 1/8" = 1'-0" PAGE: 1		BUILDER: QUALITY CRAFTED HOMES 325 COUNTY ROAD 25 NARROWSBURG, NY 12764 HOMEOWNER: SYNDER SITE: RT 97 CALLICOON CALLICOONG, NY 12723 RANCH CTM-R ELEVATIONS  Westchester Modular Homes Inc 30 Reagans Mill Road, Wingdale, New York, 12594 Tel (914)832-9400 Fax (914)832-6698		SERIAL No. 03124 PRODUCTION No. 4066 <table><tr><td>REVISION</td><td>DATE</td></tr><tr><td>LTRACEY</td><td>7-22-03</td></tr><tr><td>LTRACEY</td><td>8-12-03</td></tr><tr><td> </td><td> </td></tr><tr><td> </td><td> </td></tr><tr><td> </td><td> </td></tr><tr><td> </td><td> </td></tr><tr><td>CHECK</td><td>DATE</td></tr><tr><td> </td><td> </td></tr><tr><td> </td><td> </td></tr></table>		REVISION	DATE	LTRACEY	7-22-03	LTRACEY	8-12-03									CHECK	DATE					PE / RA THIRD PARTY INSPECTION AGENCY	
REVISION	DATE																										
LTRACEY	7-22-03																										
LTRACEY	8-12-03																										
CHECK	DATE																										

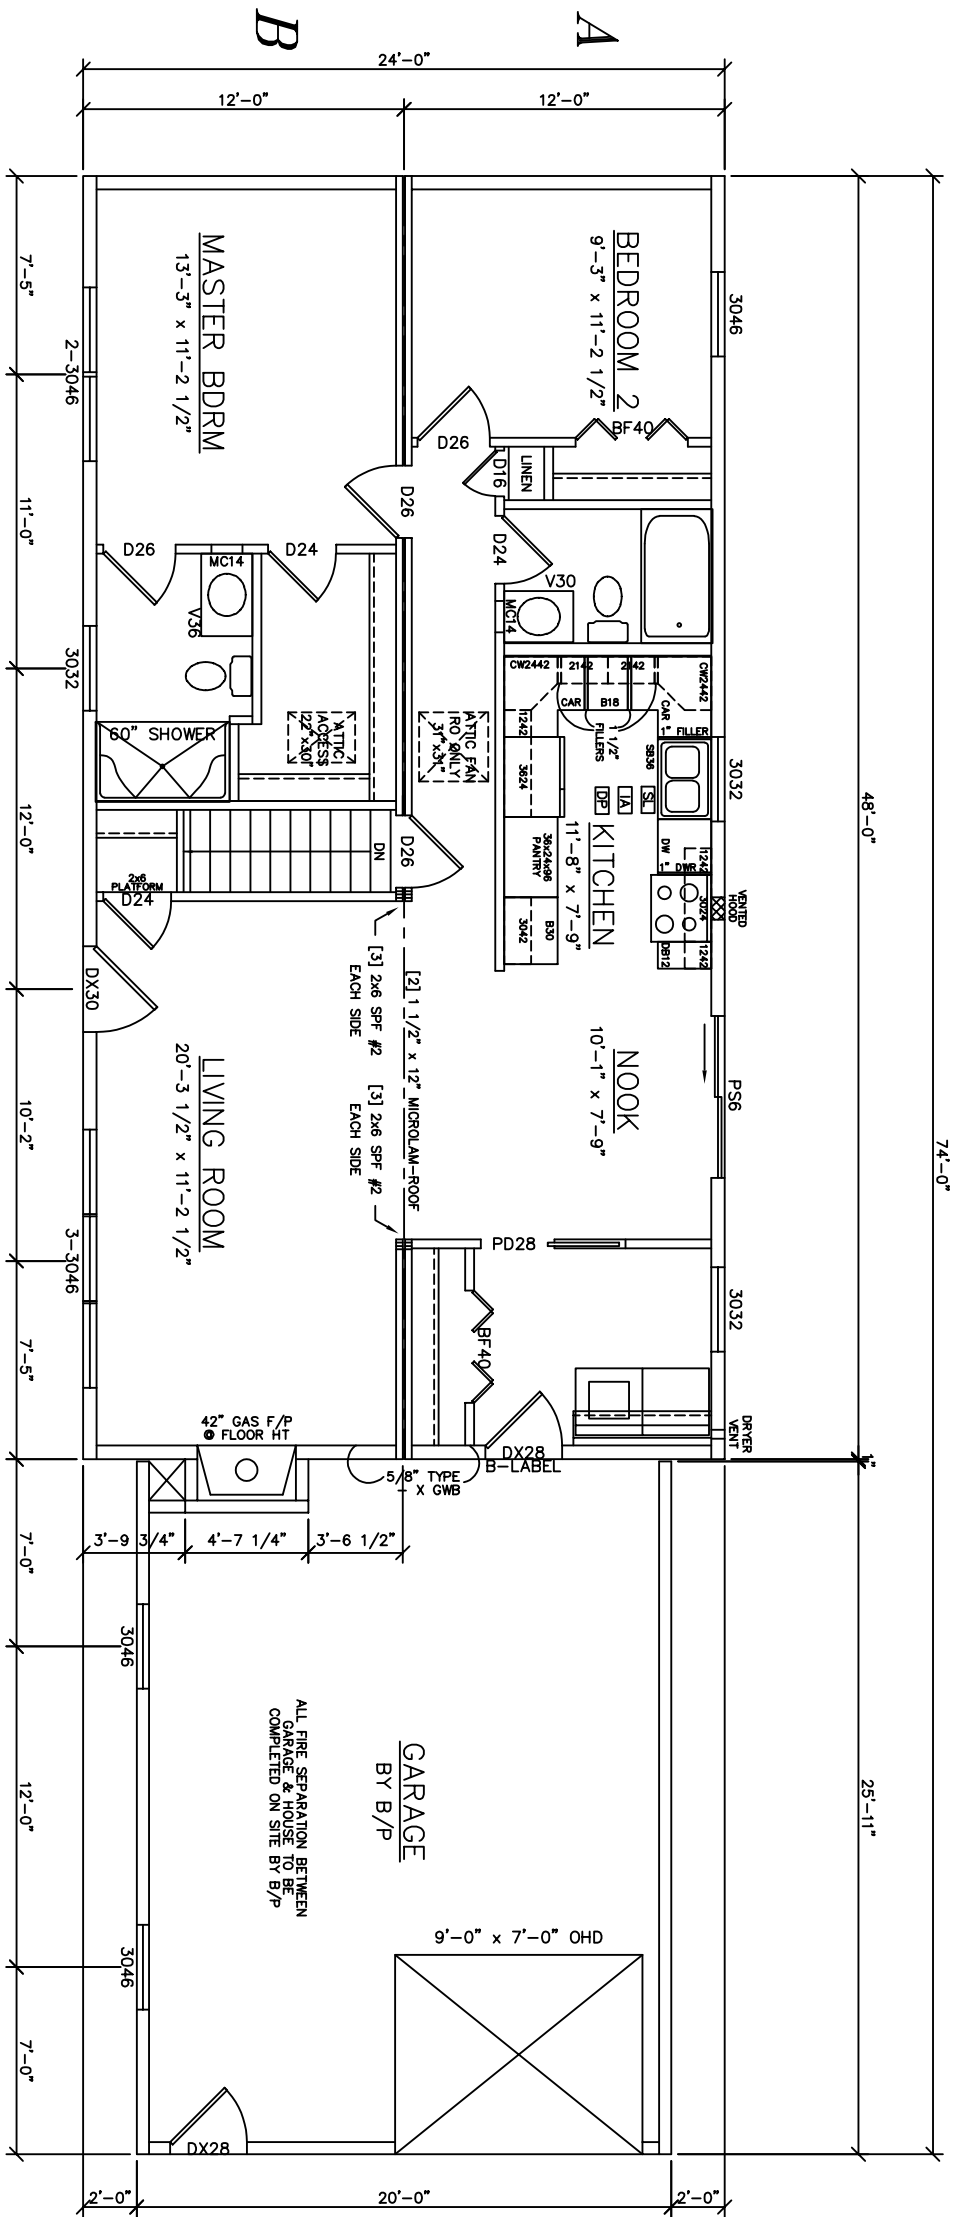

LIGHT & VENTILATION SCHEDULE (SF)

ROOM	AREA	LIGHT		VENT	
		REQUIRED	SUPPLIED	REQUIRED	SUPPLIED
MASTER BDRM	149	11.9	20.6	5.96	11.46
LIVING ROOM	227	18.2	30.9	9.08	17.19
NOOK	78	6.3	32.4	3.12	15.56
KITCHEN	90	7.2	6.9	3.60	3.85
BEDROOM 2	104	8.3	10.3	4.15	5.73

SEE STANDARD NOTES & DETAILS DWG #8

USE GROUP: SINGLE FAMILY	BUILDER: QUALITY CRAFTED HOMES	HOMEOWNER: SNYDER	SERIAL No. 03124	PE / RA		THIRD PARTY INSPECTION AGENCY
CONST. TYPE: 5B	325 COUNTY RD 25 NARROWSBURG, NY 12764	SITE: RT 97 CALLICOON CALLICOON, NY 12723	PRODUCTION No. 4066			
DESIGNER: LTRACEY	RANCH CTM-R		REVISION	DATE		
DATE: 05-23-03			LTRACEY	7-23-03		
SCALE: 3/16" = 1'-0"	FIRST FLOOR PLAN		LTRACEY	8-26-03		
PAGE: 3A						
			CHECK	DATE		
	Westchester Modular Homes Inc					
	30 Reagans Mill Road, Wingdale, New York, 12594					
	Tel (914)832-9400 Fax (914)832-6698					