


LIGHT & VENTILATION SCHEDULE (SF)			
ROOM	AREA	LIGHT SUPPLIED	VENT SUPPLIED
KITCHEN	201	6.9	3.85
DINING RM	120	32.4	15.56
LIVING RM	172	30.9	17.19
MBDRM	204	20.6	11.46

COMBINE


- SEE PAGE 3C FOR GARAGE PLAN -

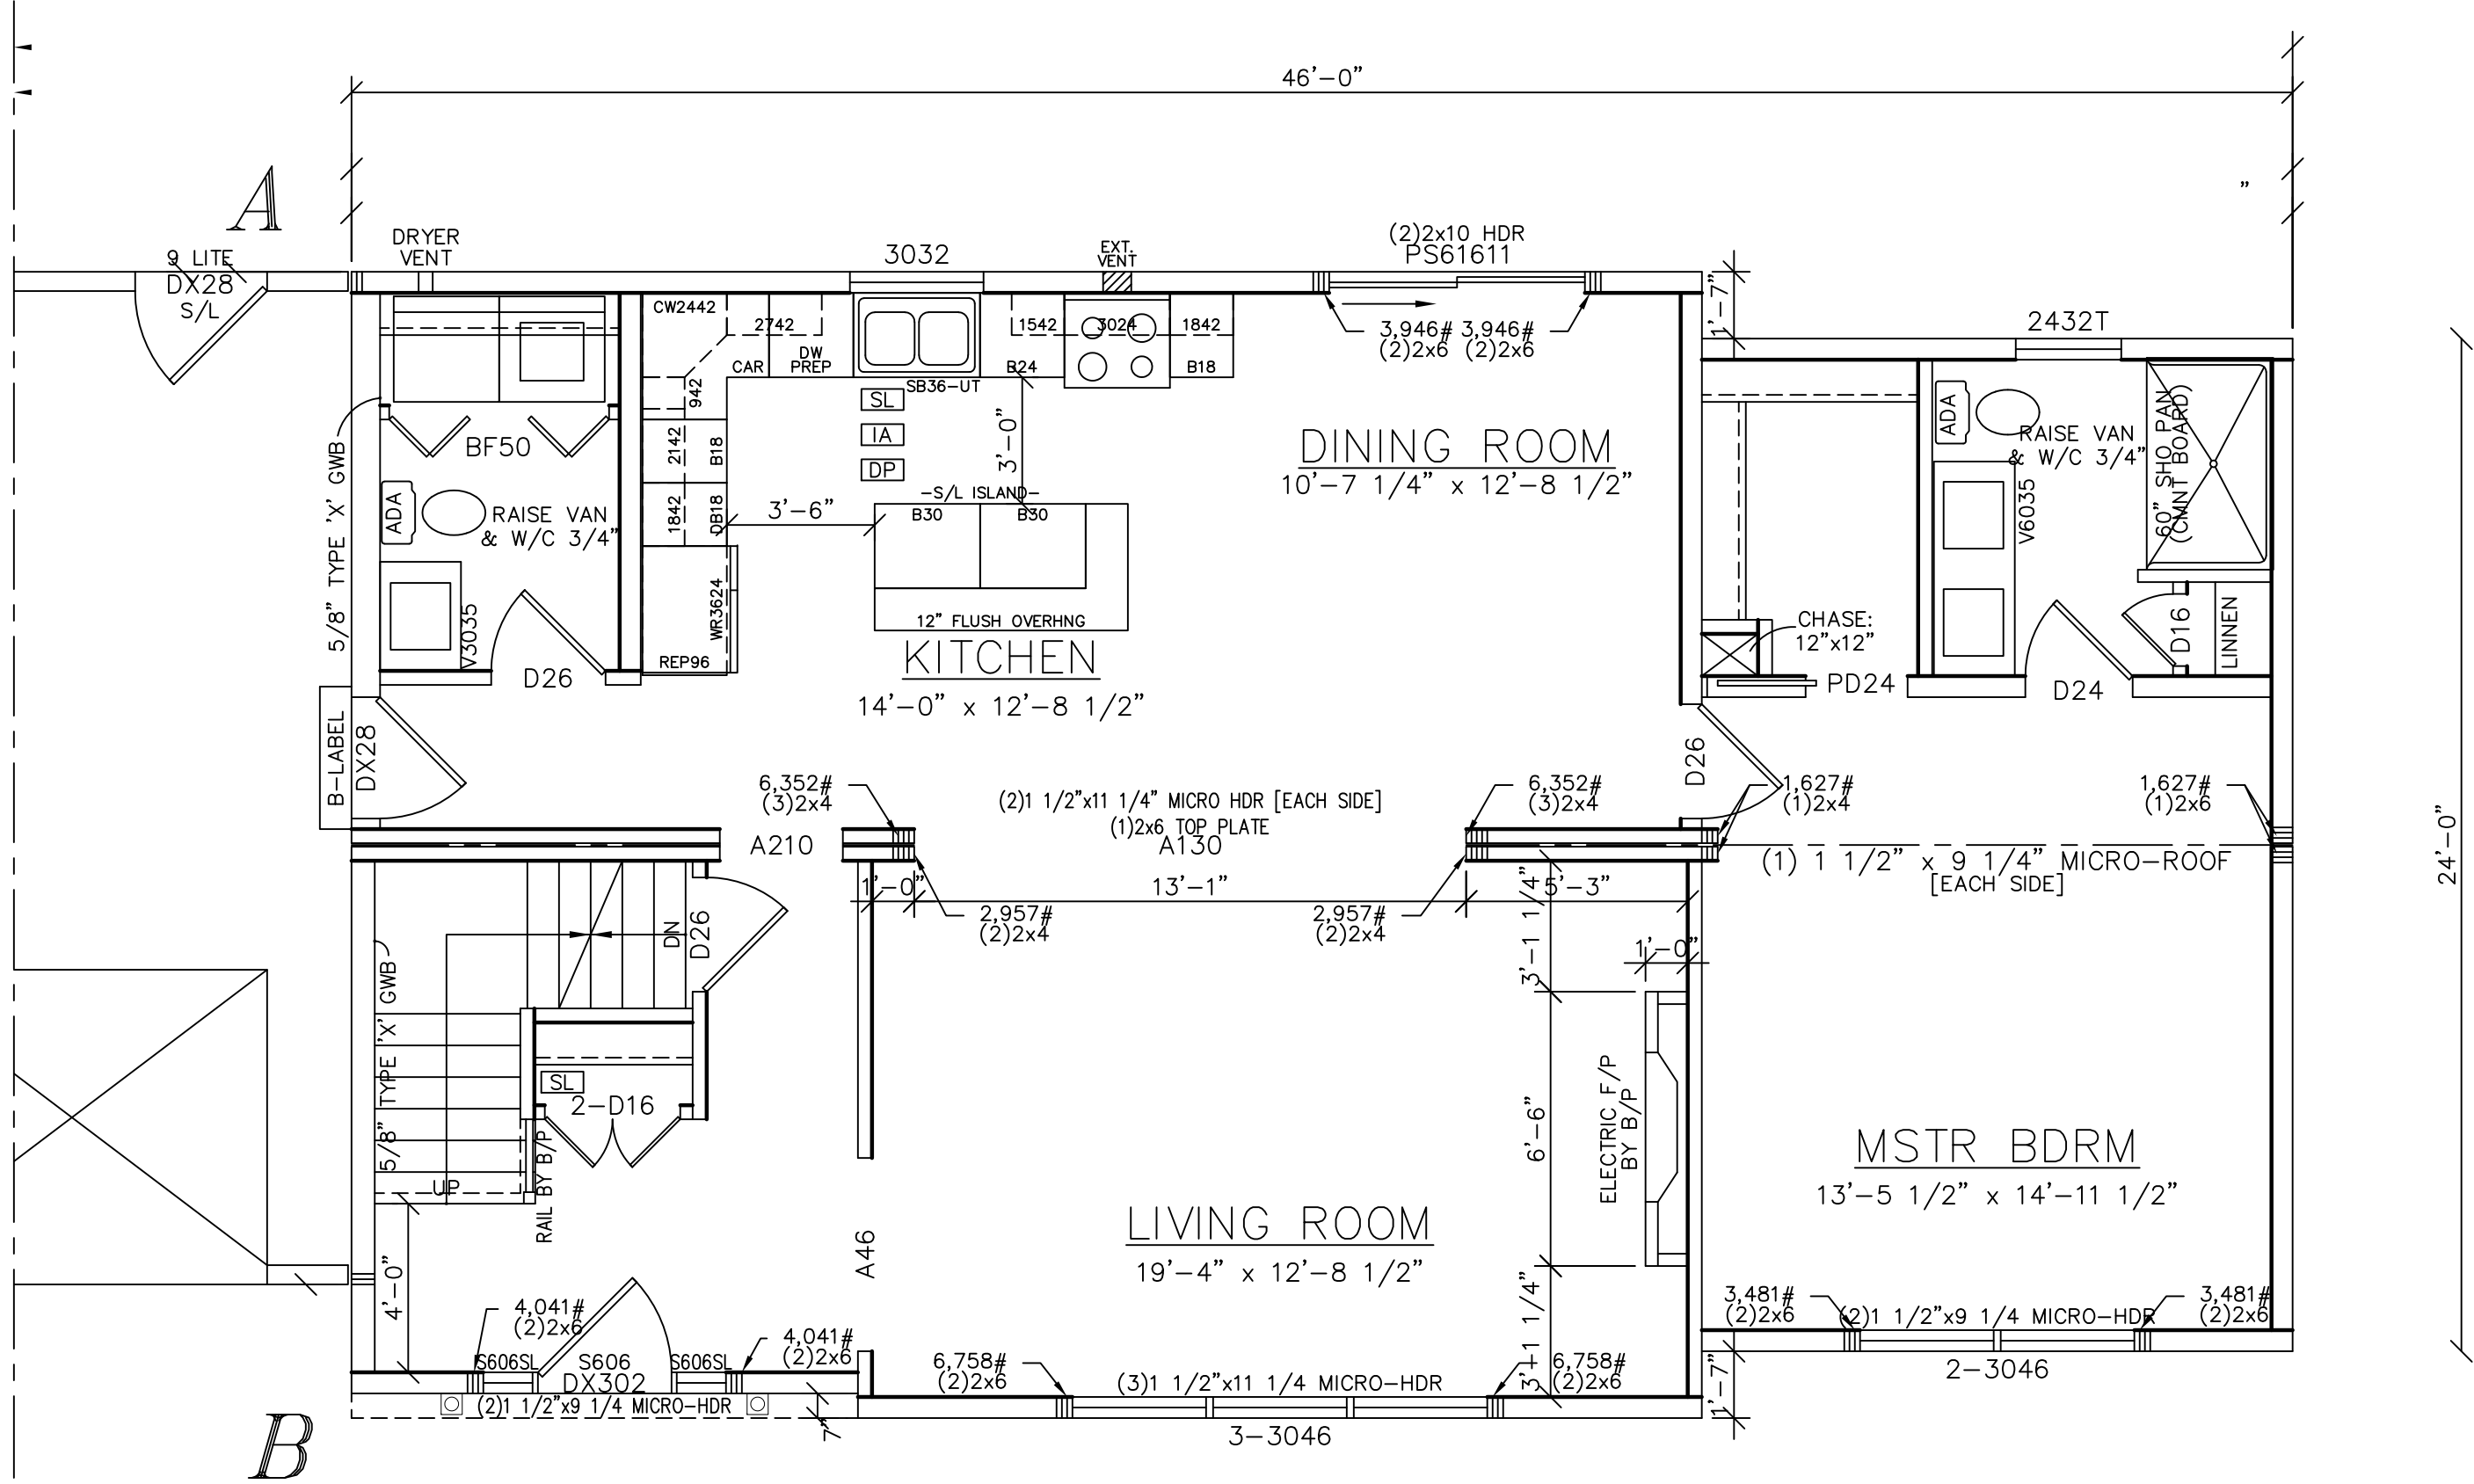

SEE STANDARD NOTES & DETAILS DWG #8

USE GROUP: SINGLE FAMILY		BUILDER:	HOMEOWNER:	SERIAL No. 24140		PE / RA		THIRD PARTY INSPECTION AGENCY			
CONST. TYPE: VB		DESIGNER: R. SEAMAN		PRODUCTION No.							
DATE: 08/09/2024		REVISION		DATE							
SCALE: 1/4" = 1'-0"											
PAGE: 3A											
CONCORD MOD-R FIRST FLOOR PLAN				CHECK		DATE					
Westchester Modular Homes Inc 30 Reagans Mill Road, Wingdale, New York, 12594 Tel (845)832-9400 Fax (845)832-6698											

LIGHT & VENTILATION SCHEDULE (SF)			
ROOM	AREA	LIGHT SUPPLIED	VENT SUPPLIED
BDRM 2	123	19.8	11.52
BDRM 3	130	19.8	11.52
.	.	.	.
.	.	.	.
.	.	.	.

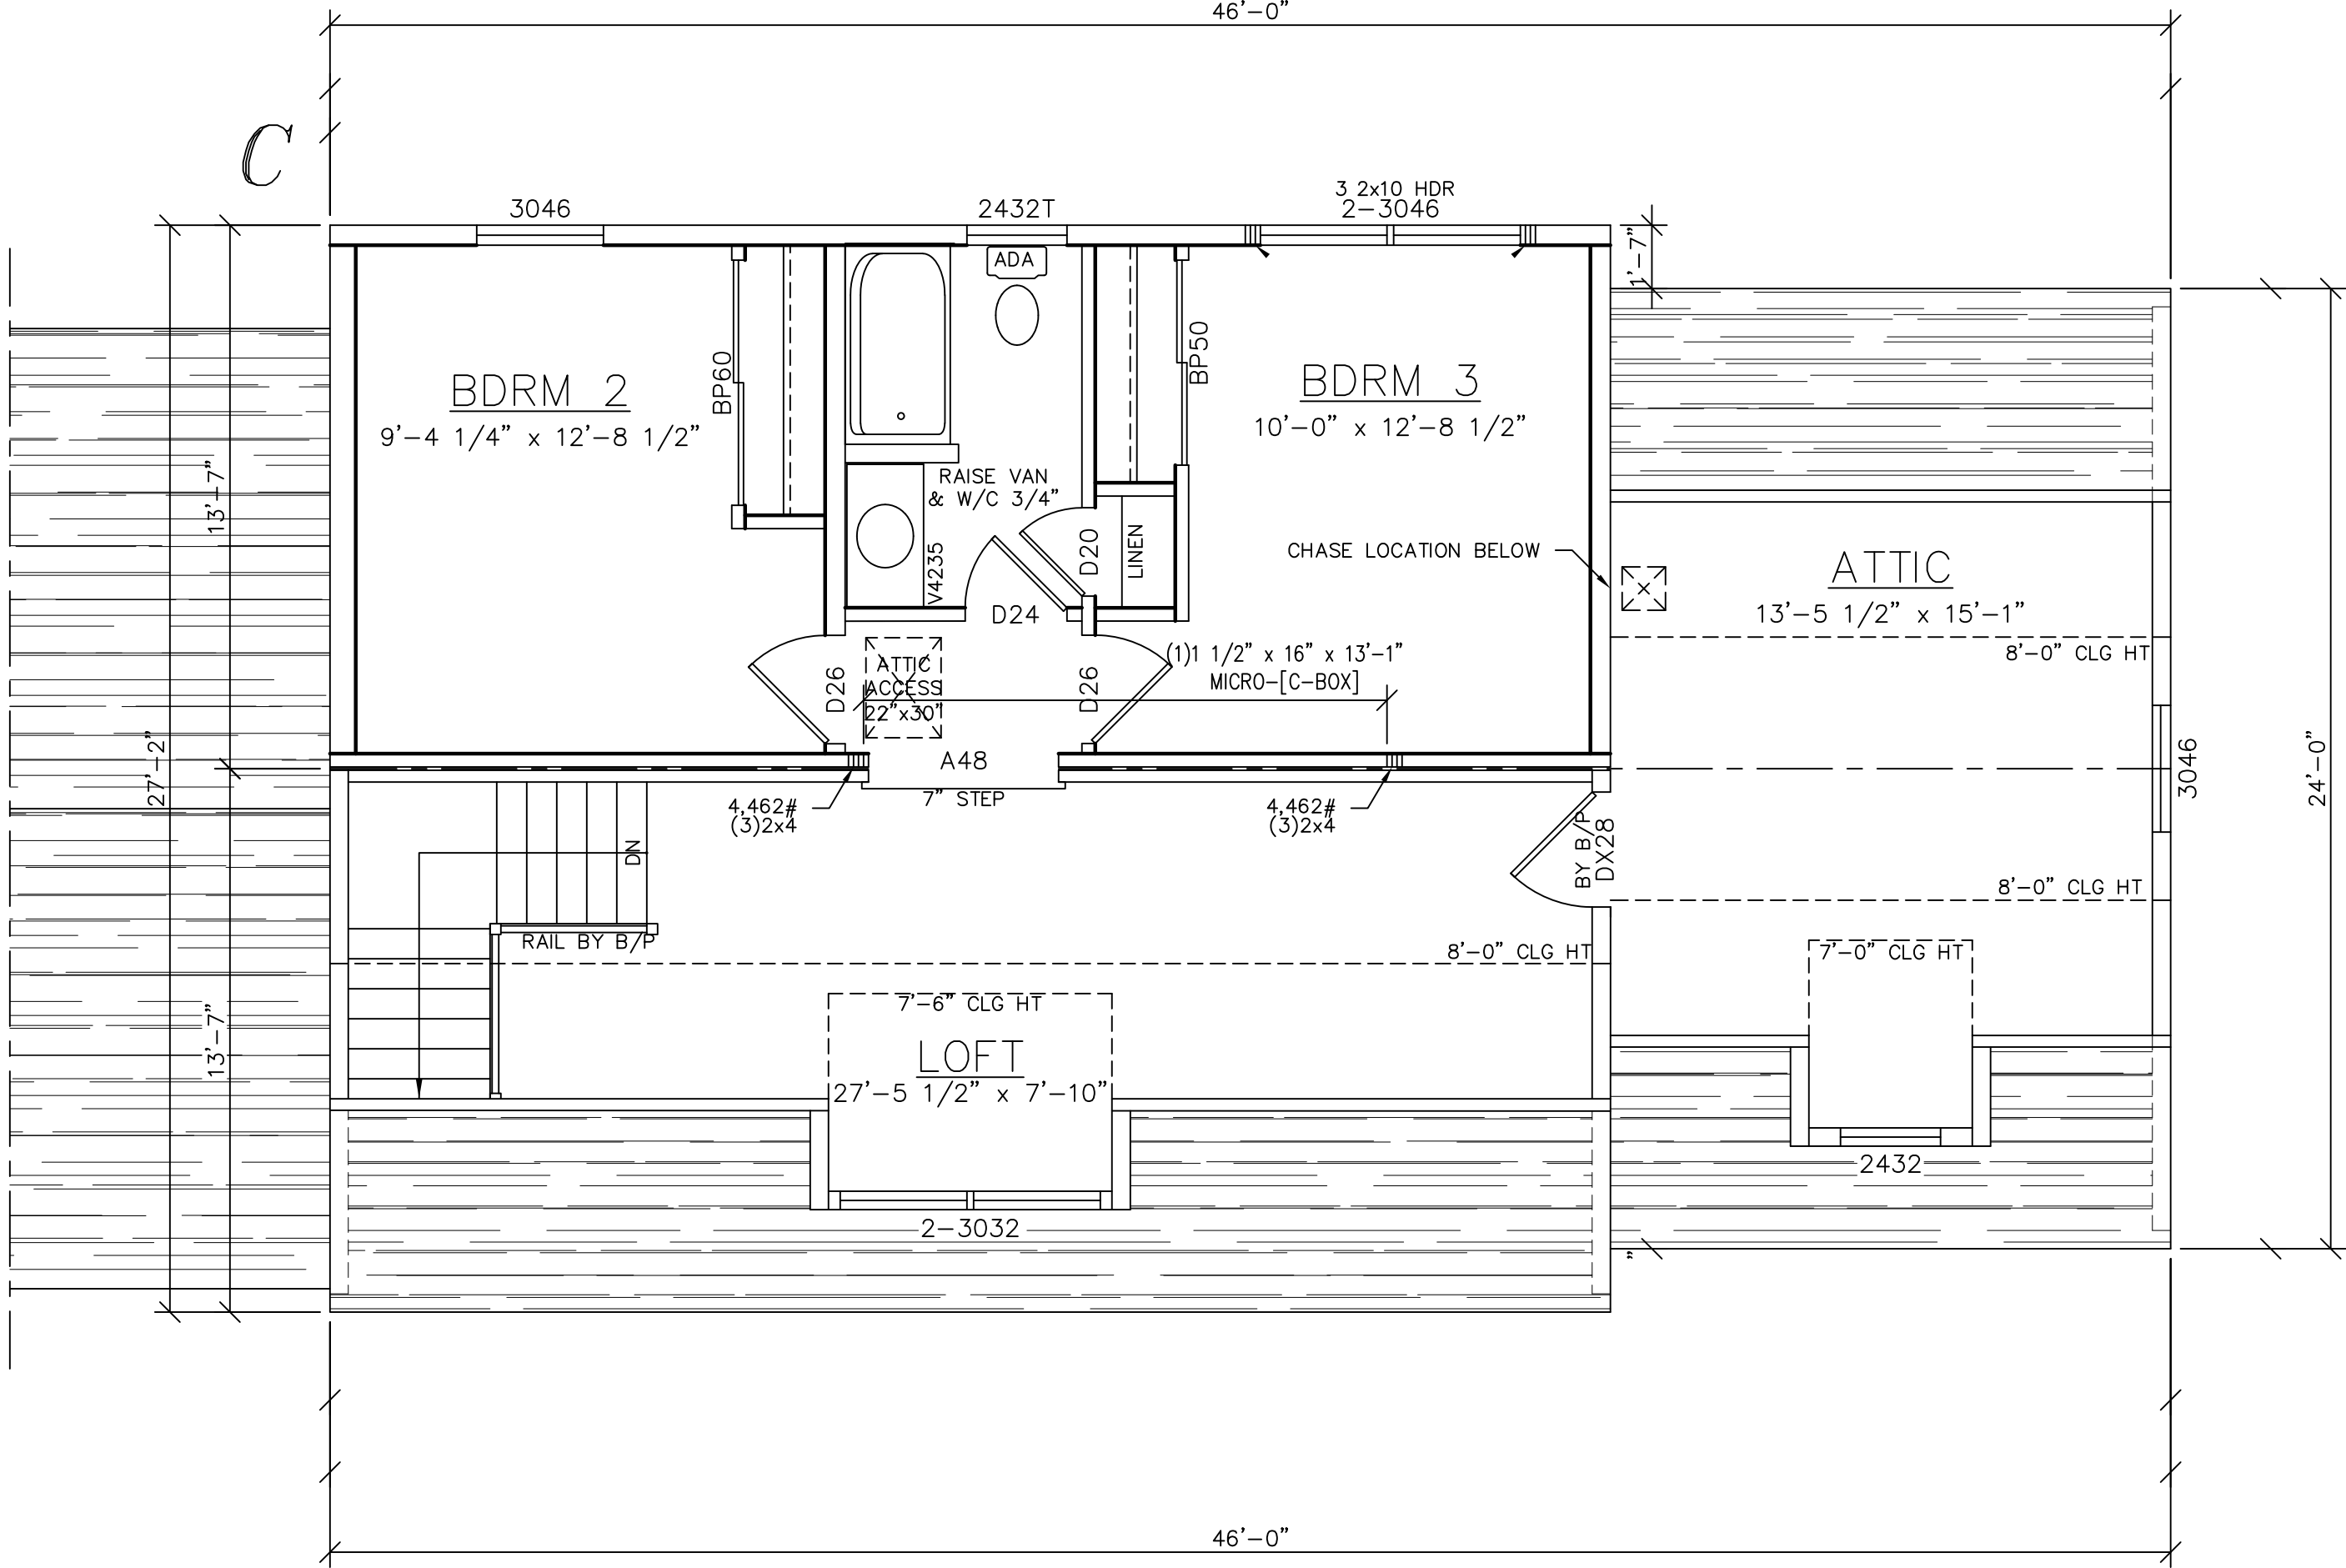

SEE STANDARD NOTES & DETAILS DWG #8

USE GROUP: SINGLE FAMILY		CONST. TYPE: VB	BUILDER: -	HOMEOWNER: -	SERIAL No. 24140		PE / RA		THIRD PARTY INSPECTION AGENCY	
DESIGNER: R. SEAMAN			CONCORD MOD-R SECOND FLOOR PLAN		PRODUCTION No.					
DATE: 08/09/2024		REVISION			DATE					
SCALE: 1/4" = 1'-0"										
PAGE:		CHECK			DATE					
3B										
			Westchester Modular Homes Inc 30 Regans Mill Road, Wingdale, New York, 12594 Tel (845)832-9400 Fax (845)832-6698							